



FLOOR PLAN
SCALE: 1/4"

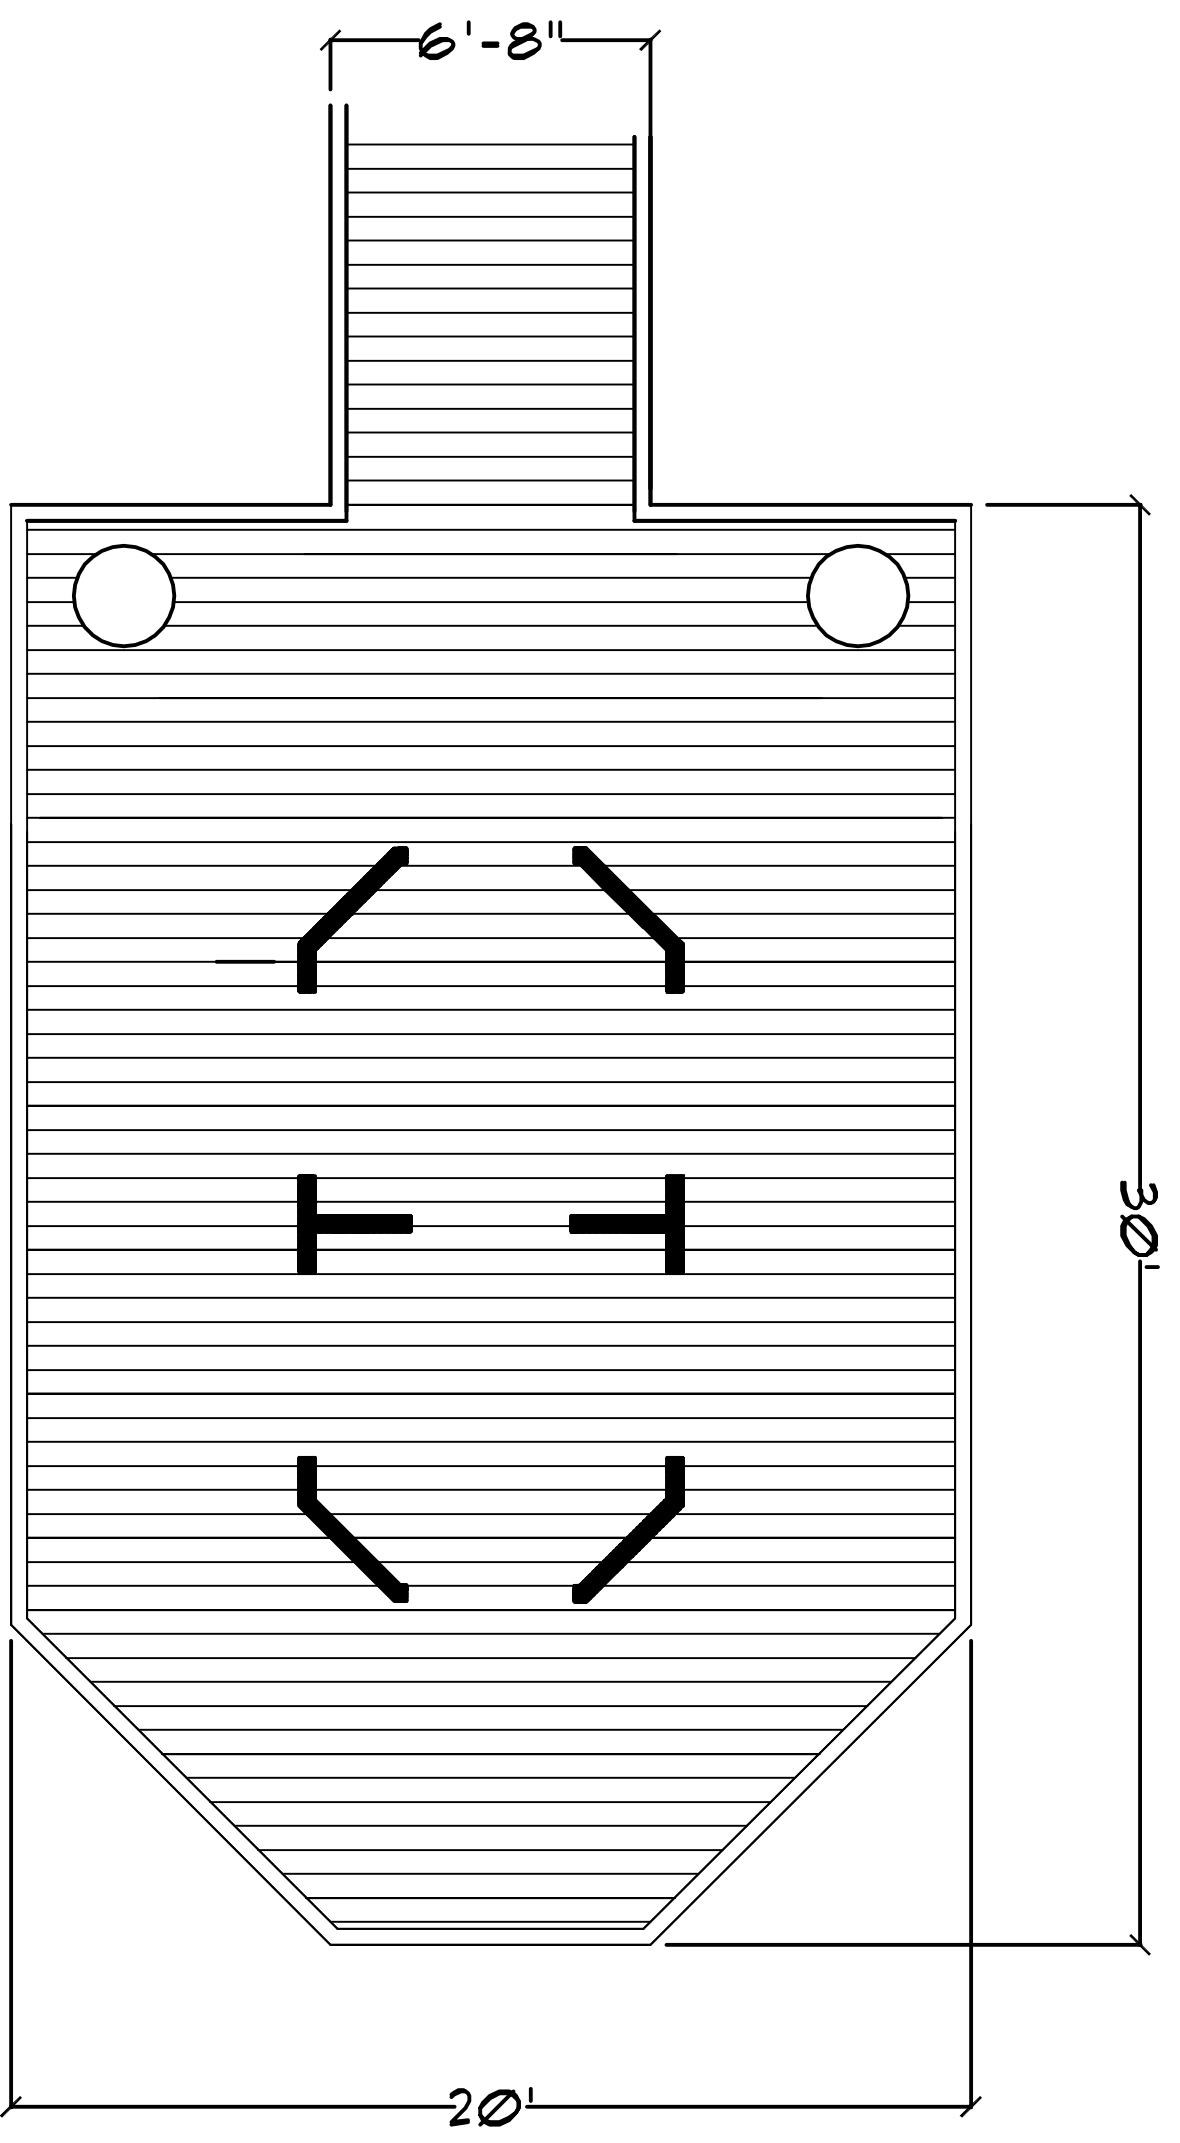

MAIN DECK PLAN
SCALE: 1/4"

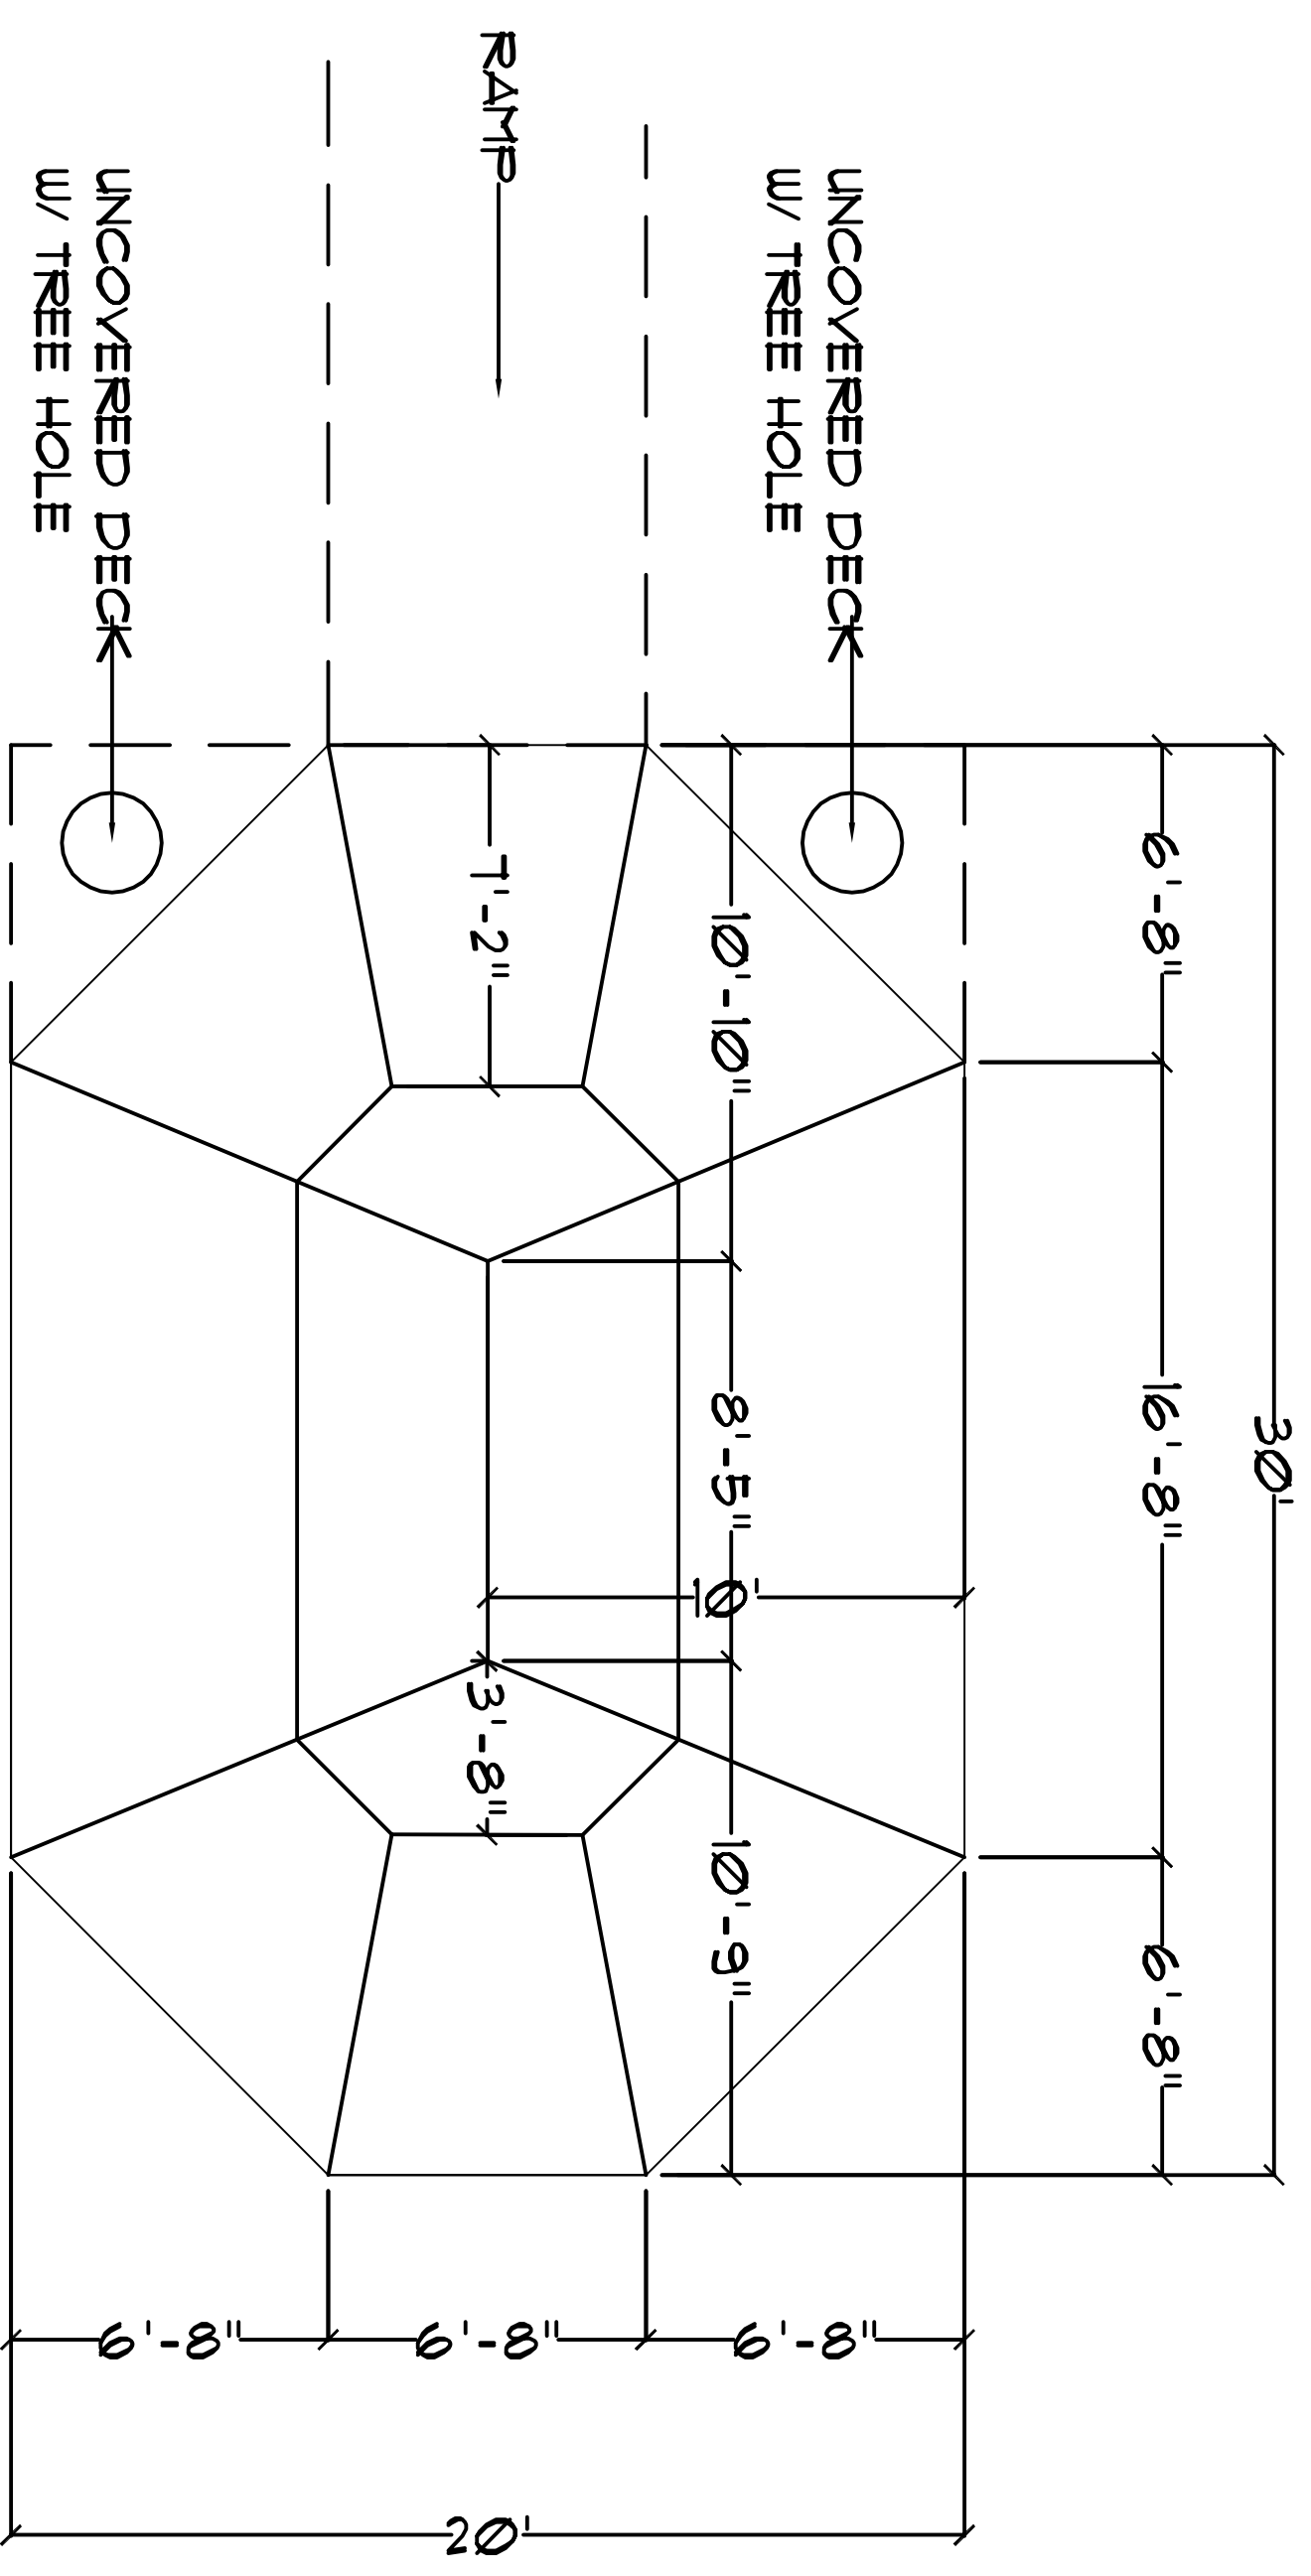

ROOF PLAN
SCALE: 1/4"

SHEET TITLE:
FLOOR/ROOF
PLAN

A-1

DRAWING NUMBER

project no. PC 2008-000
date: MARCH 2008
designed: MJP
checked: JPC
drawn: MJP

ADA TREEHOUSE
ROME, GEORGIA

PC
DESIGN BUILD
Rome, GA
44 EAST 2ND. AVE.
Phone: (706) 234-0610
Fax: (706) 234-9030